


Second Level

Scale 1/4" = 1' - 0"

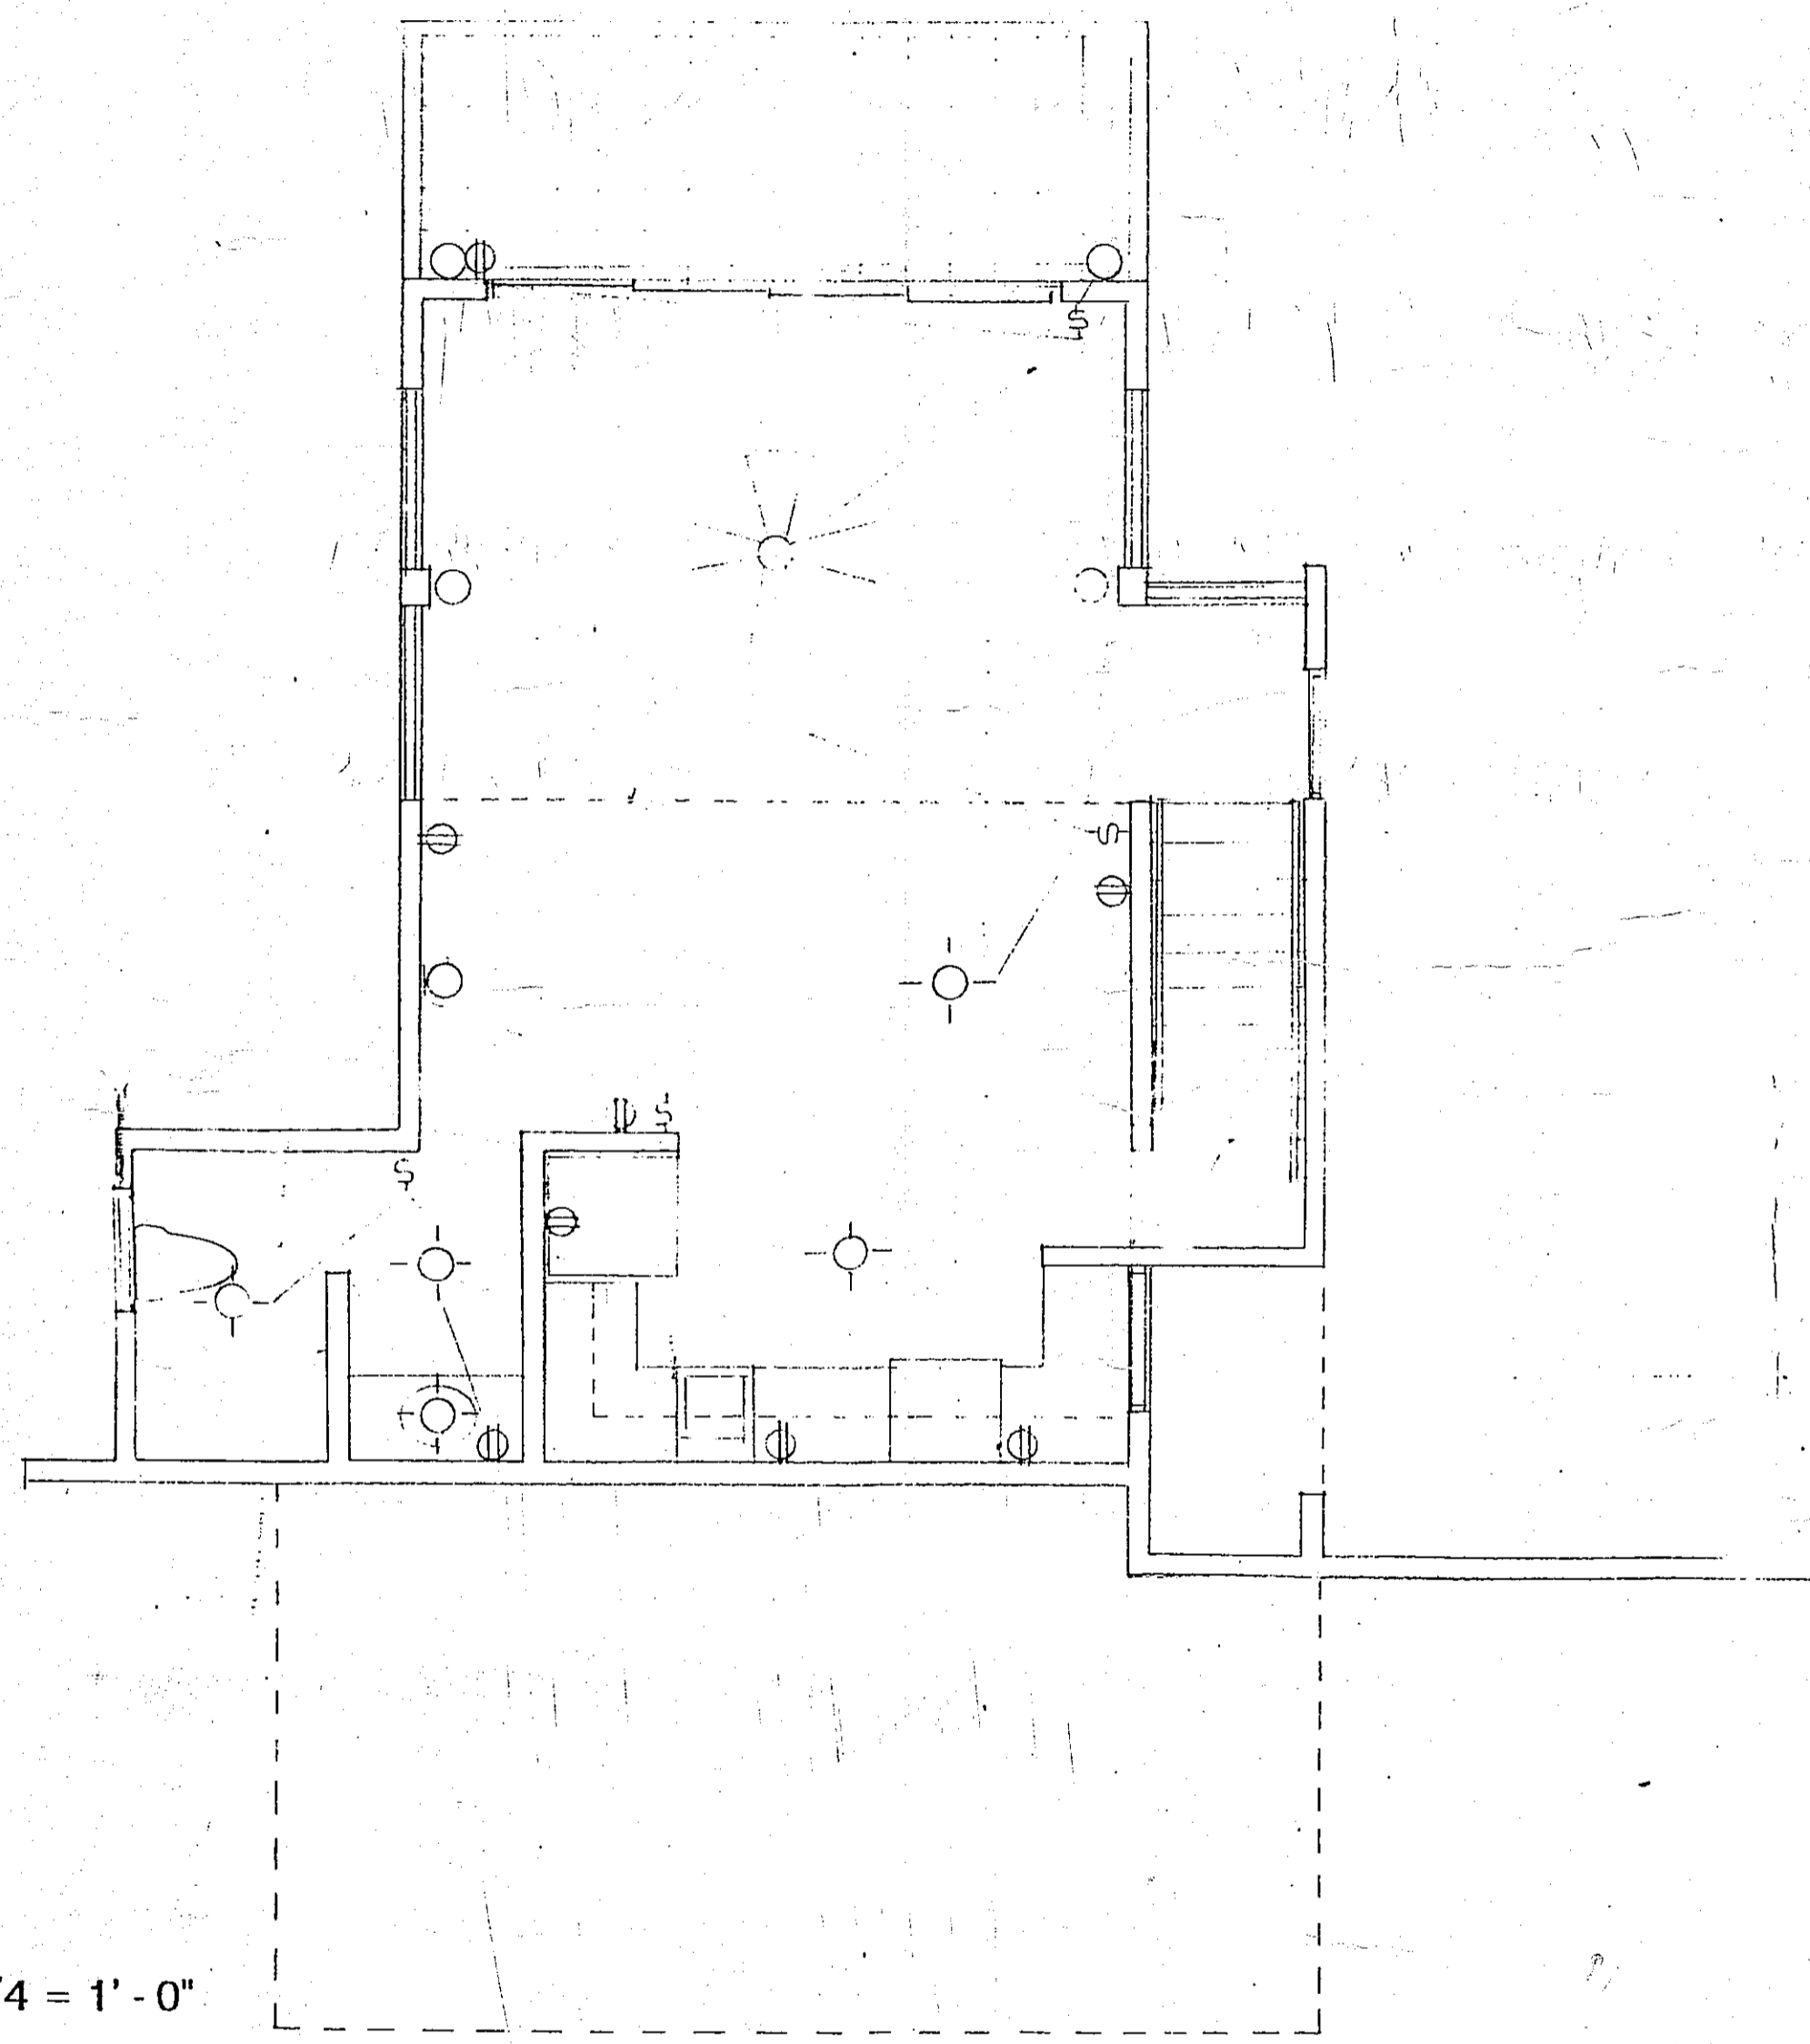

First Level

**Bahia Honda Resort
Culebra, P.R.**

Electrical Layout

NU-TEC Manufacturing Corp.
Ing. F.A. Rodriguez Molinary

Bahia Honda Resort
Culebra, P.R.

A-4