



ROOM NO.	TYPE	NO./SIZE LAMP	ROOM NO.	TYPE	NO./SIZE LAMP
103-103	E	1/200W/IE	147	D	2/75W/IE
104	A	2/40W/RS	148	J	2/100W/IE
105	E	1/50W/IE	149	J	2/100W/IE
106-125	C	3/30W/RS	150	J	2/100W/IE
126-134	D	2/75W/IE	151	J	2/100W/IE
135-136	-	2/75W/IE	152	H	2/40W/RS
137-139	-	1/50W/IE	153	D	4/40W/RS
140	I	1/50W/IE	154	D	2/75W/IE
141	I	4/40W/RS	155	J	4/20W/RS
142	P	1/100W/IE	156	H	2/40W/RS
143	P	1/100W/IE	157	H	2/40W/RS
144	G	1/300W/IE	158, A-2	F	2/200W/IE
145	AA	3/40W/RS	A-1	T	2/150W/IE
146	F	1/200W/IE	159	P	1/200W/IE
S-1,2,3,4	-	1/200W/IE	160	N	1/200W/IE


FIGURE DESIGNATION

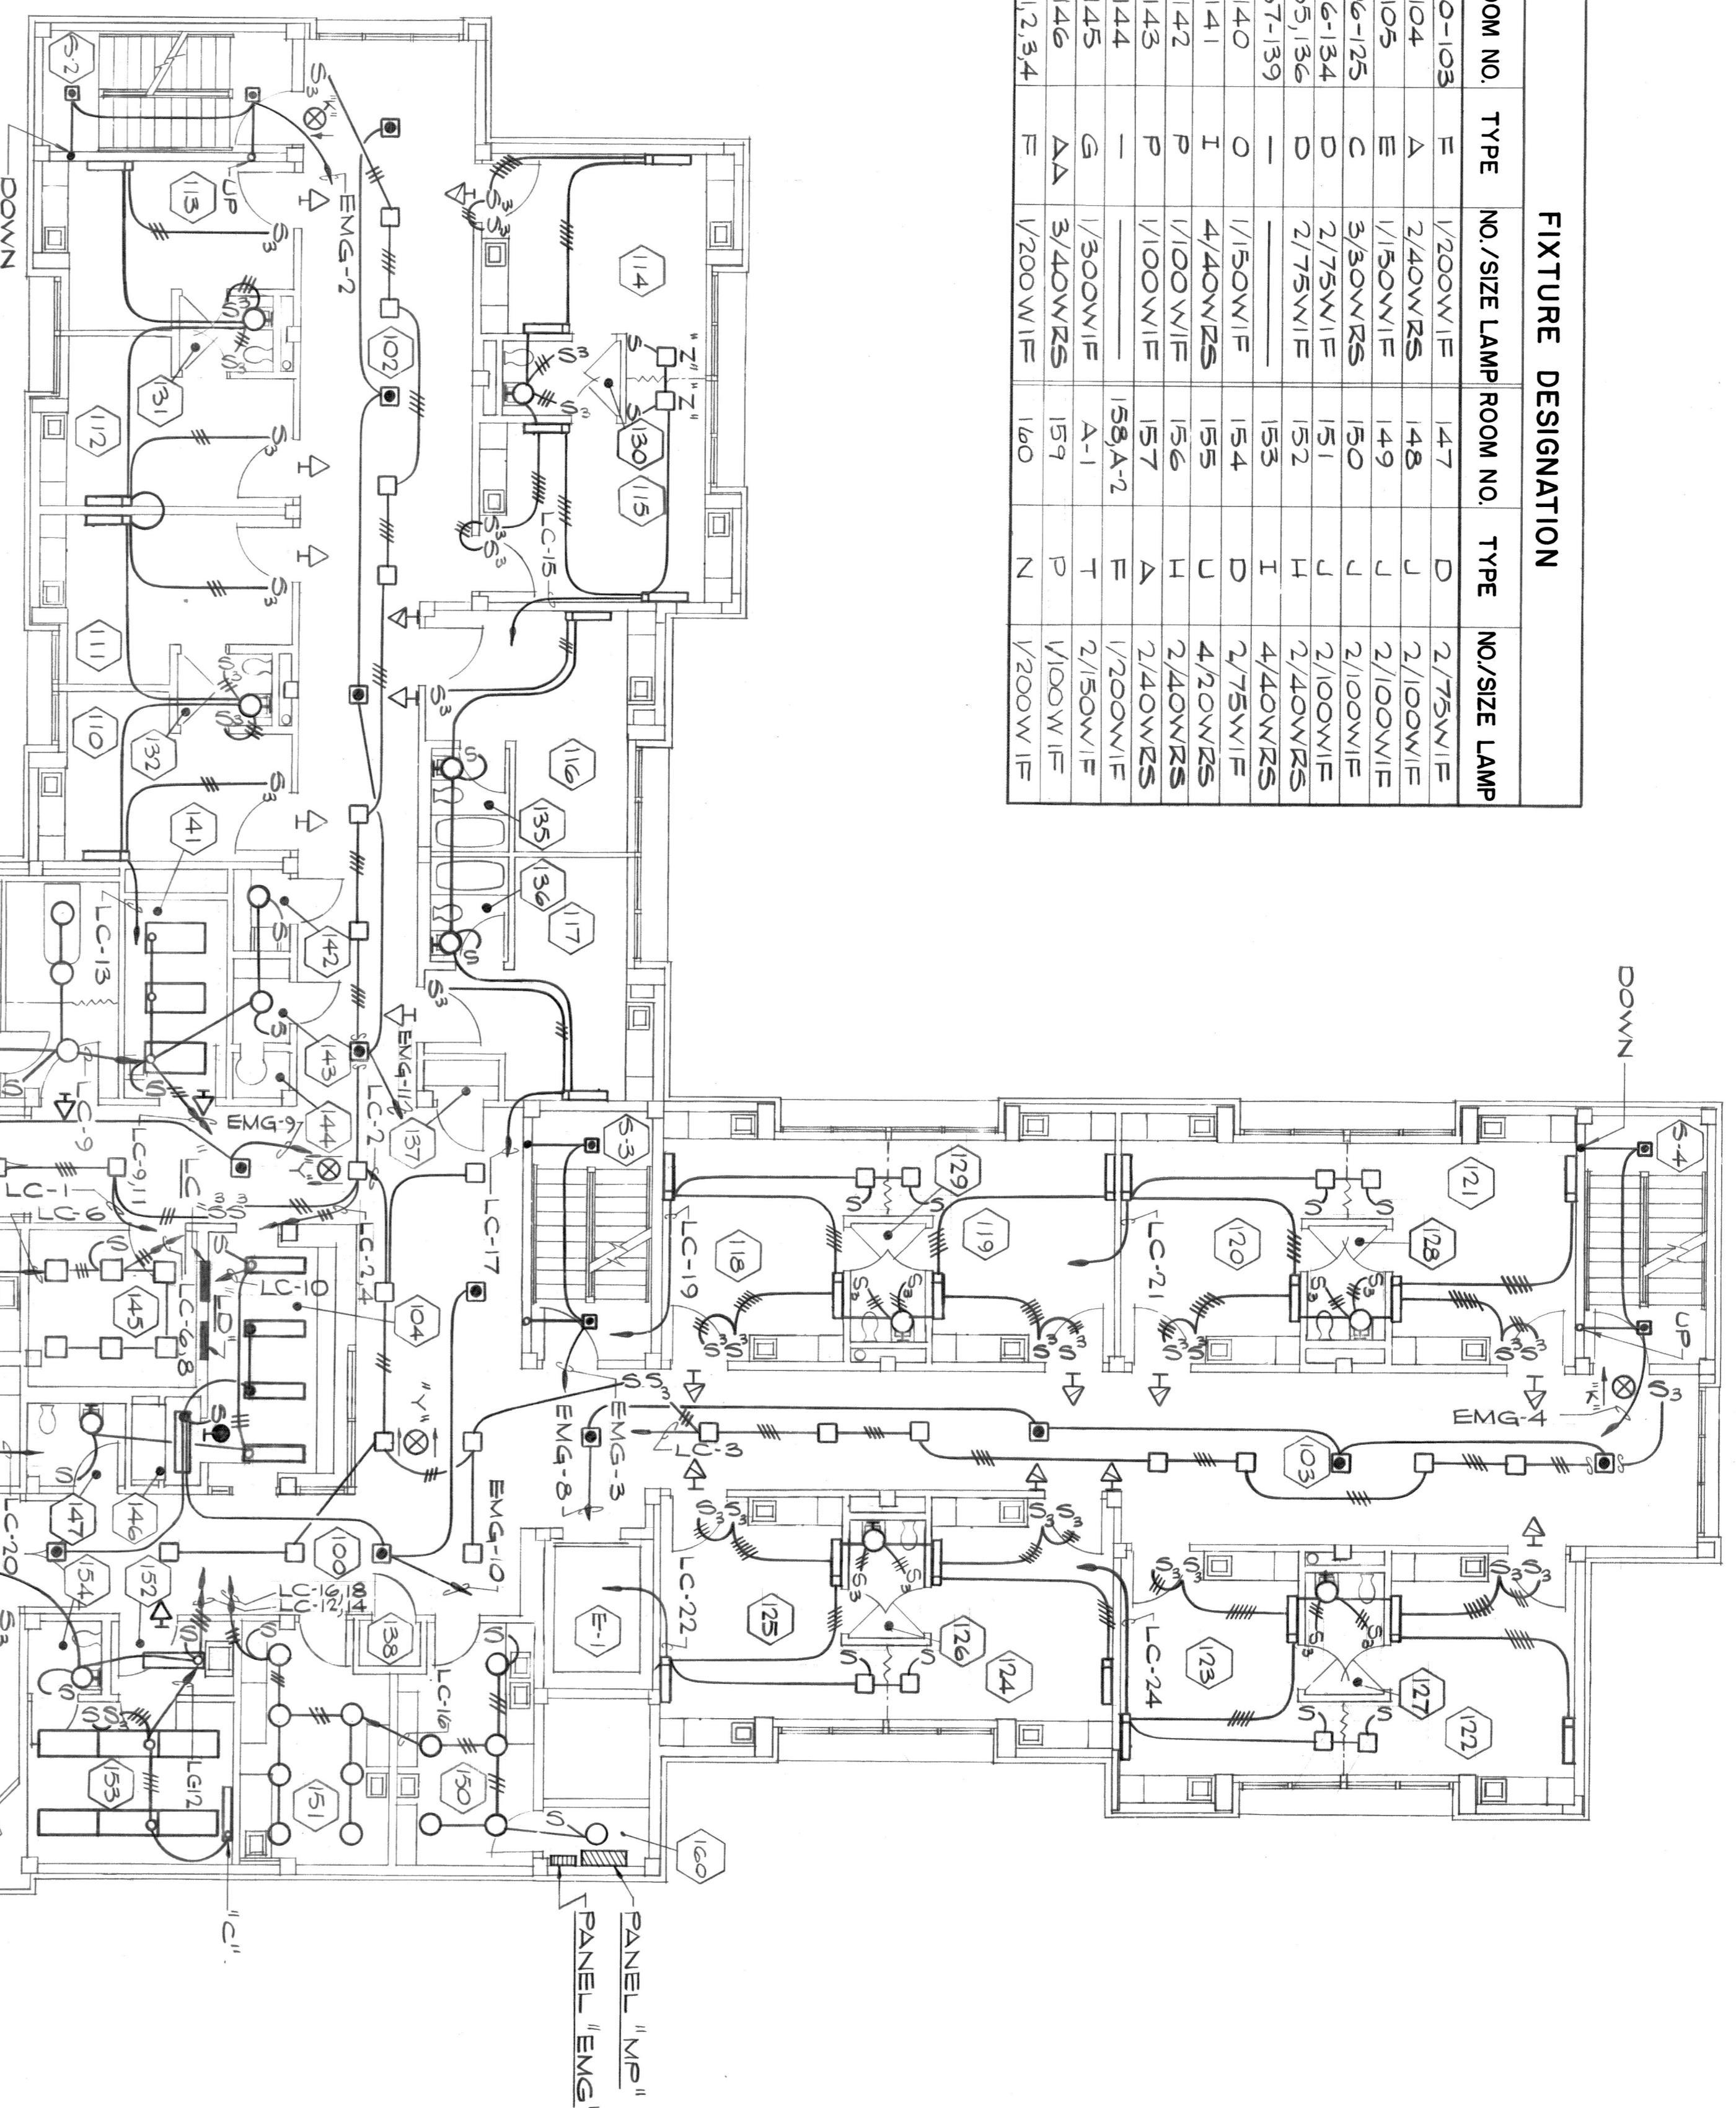

FIRST FLOOR PLAN - LIGHTING
1/8" = 1'-0"

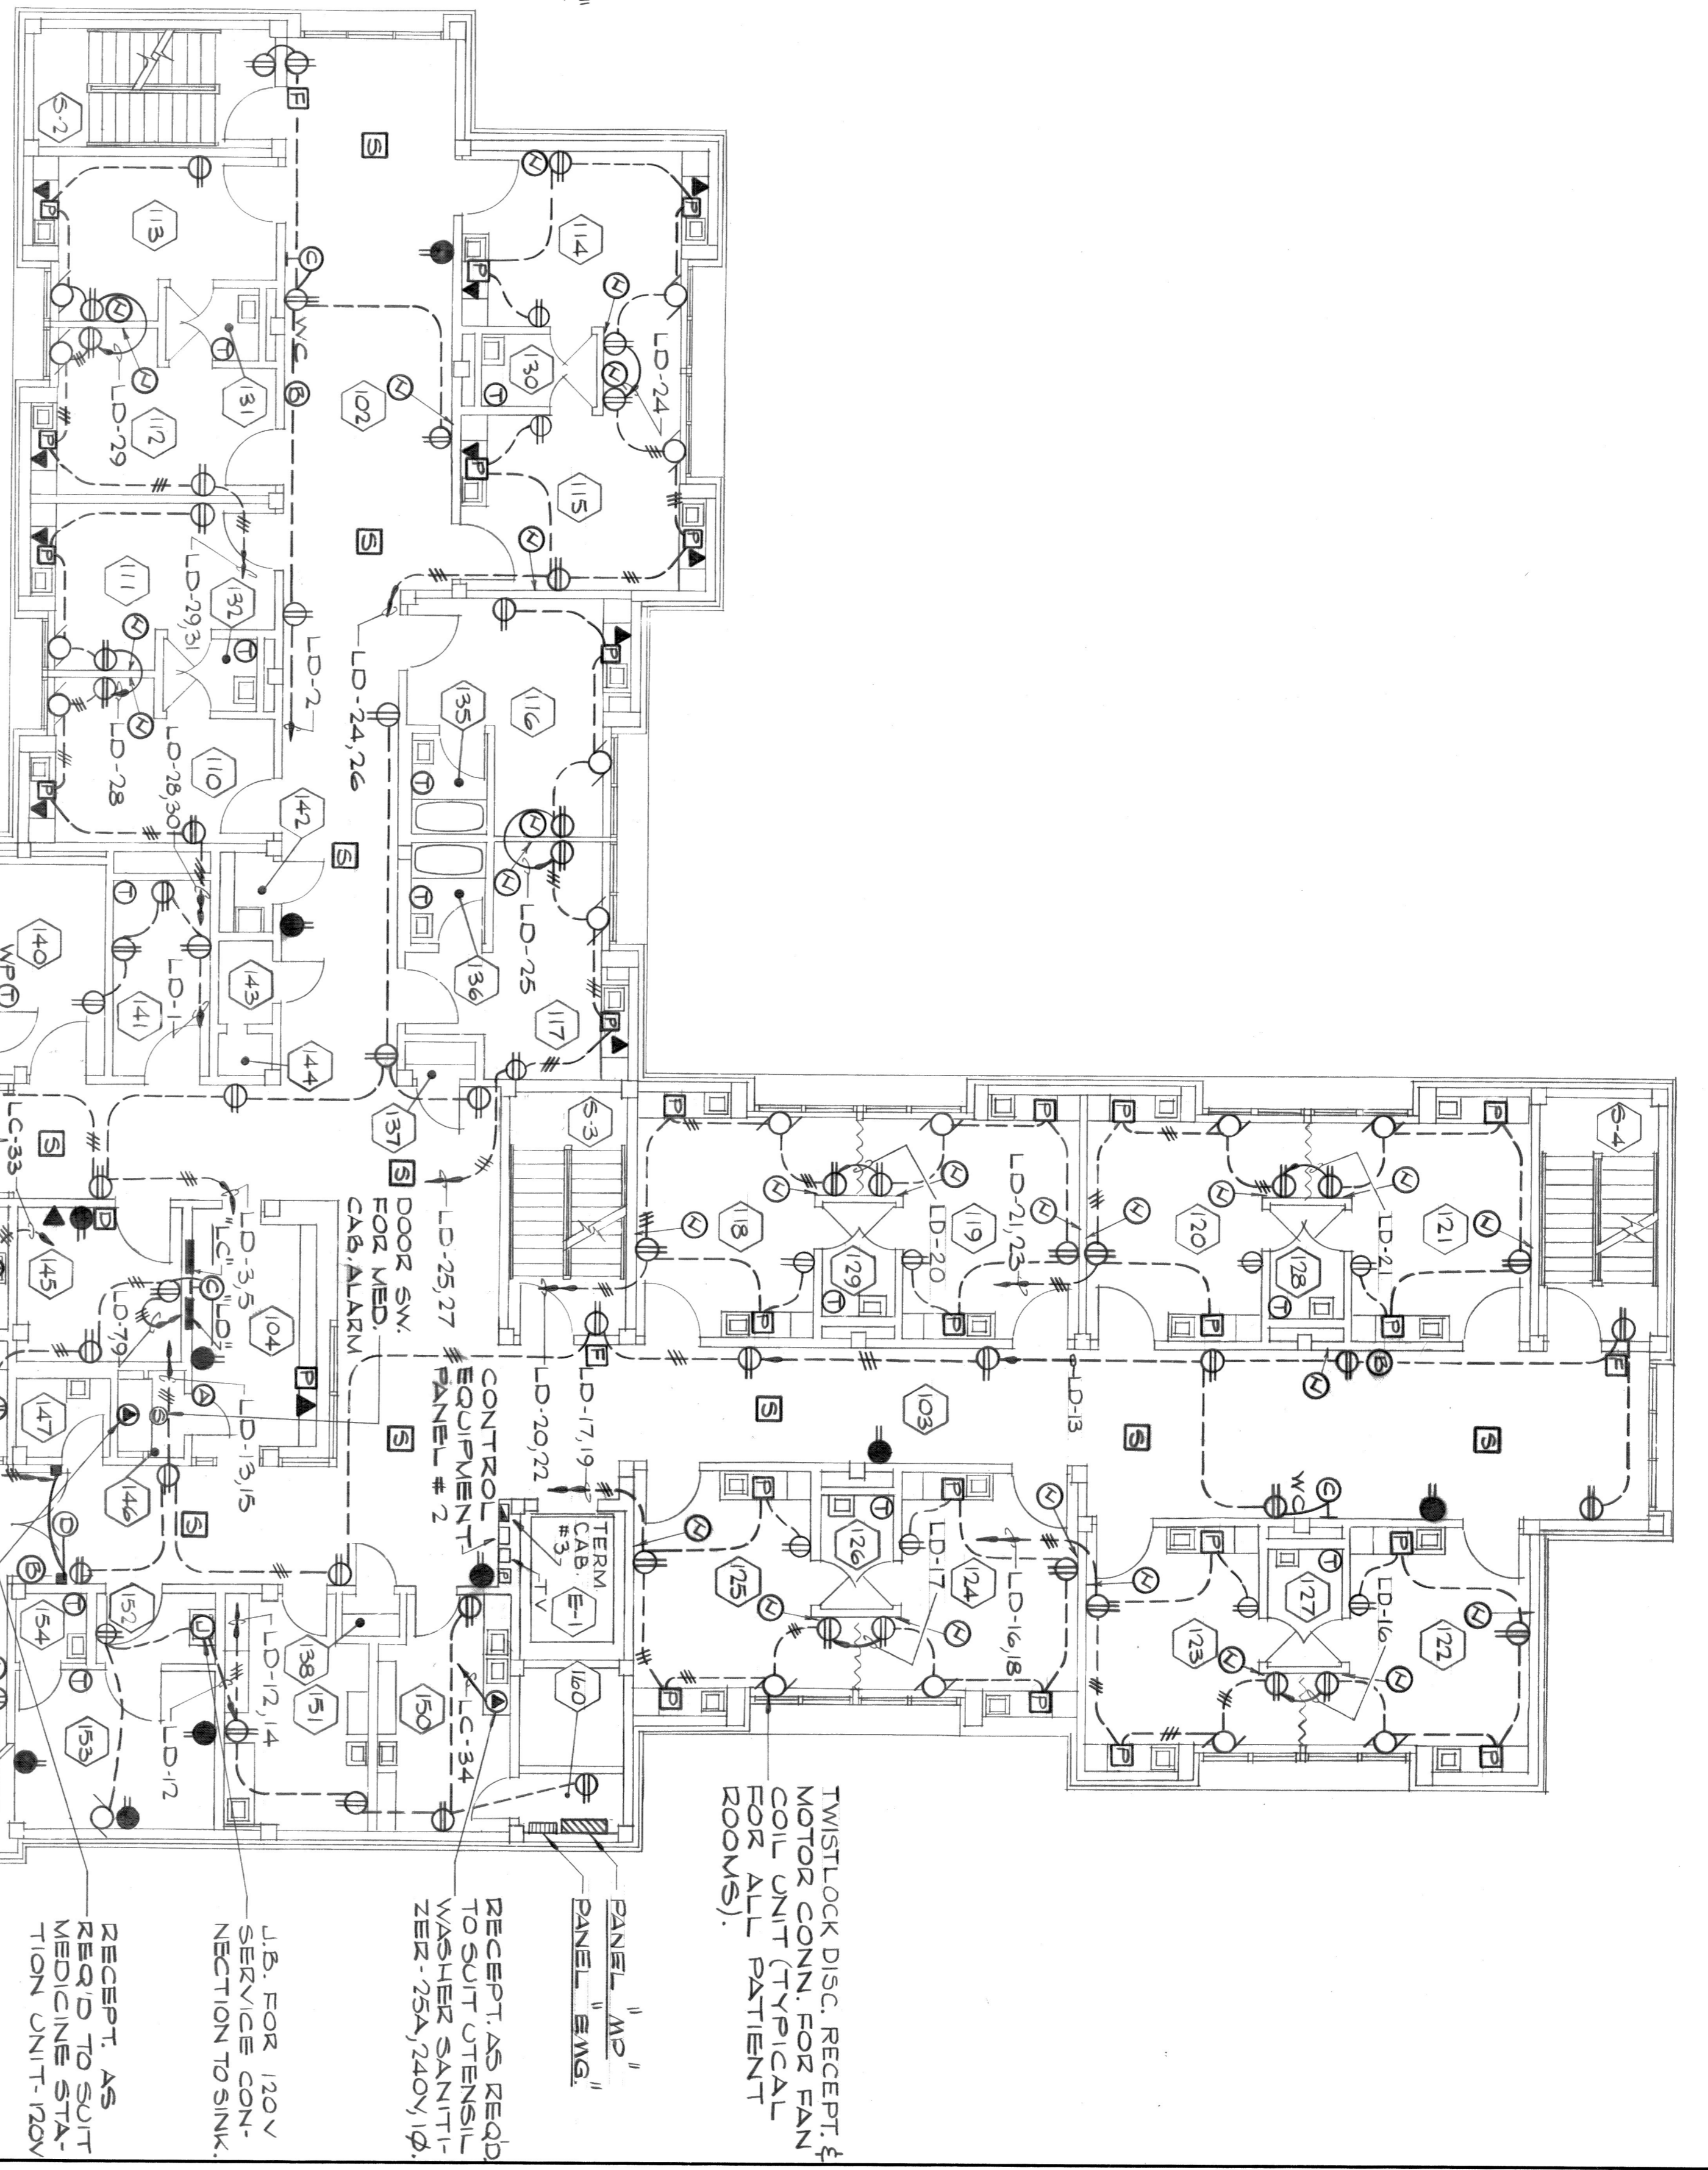

FIRST FLOOR PLAN - POWER
1/8" = 1'-0"

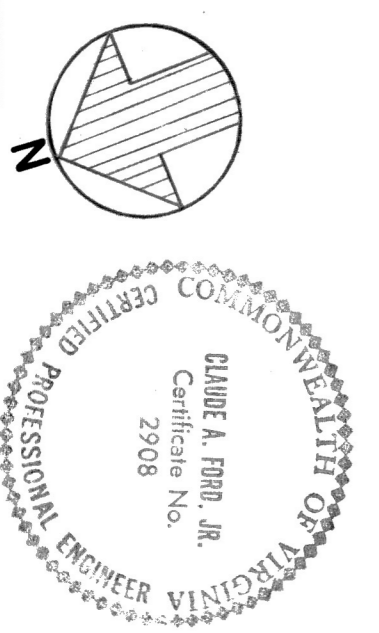

ALTERATIONS & ADDITIONS
TO
GUGGENHEIMER MEMORIAL
HOSPITAL
LYNCHBURG, VIRGINIA

CLARK, MEYSEN & OWEN - ARCHITECTS
LYNCHBURG, VIRGINIA
NORFOLK, VIRGINIA

DATE: 10/68
DRAWN BY: JWB
CHECKED BY: JWB
SCALE: AS NOTED

FIRST FLOOR PLAN -
LIGHTING & POWER

E - 3